


**FLOOR PLAN - HVAC RETURN & SUPPLY DUCTWORK**  
SCALE: 1/8"=1'-0"



**FLOOR PLAN - HVAC PIPING & O/A DUCTWORK**  
SCALE: 1/8"=1'-0"

Codefile: 40567 M200.dwg  
PROJ: # G:\Users\2007\07045\cod\ Date: 01/16/08

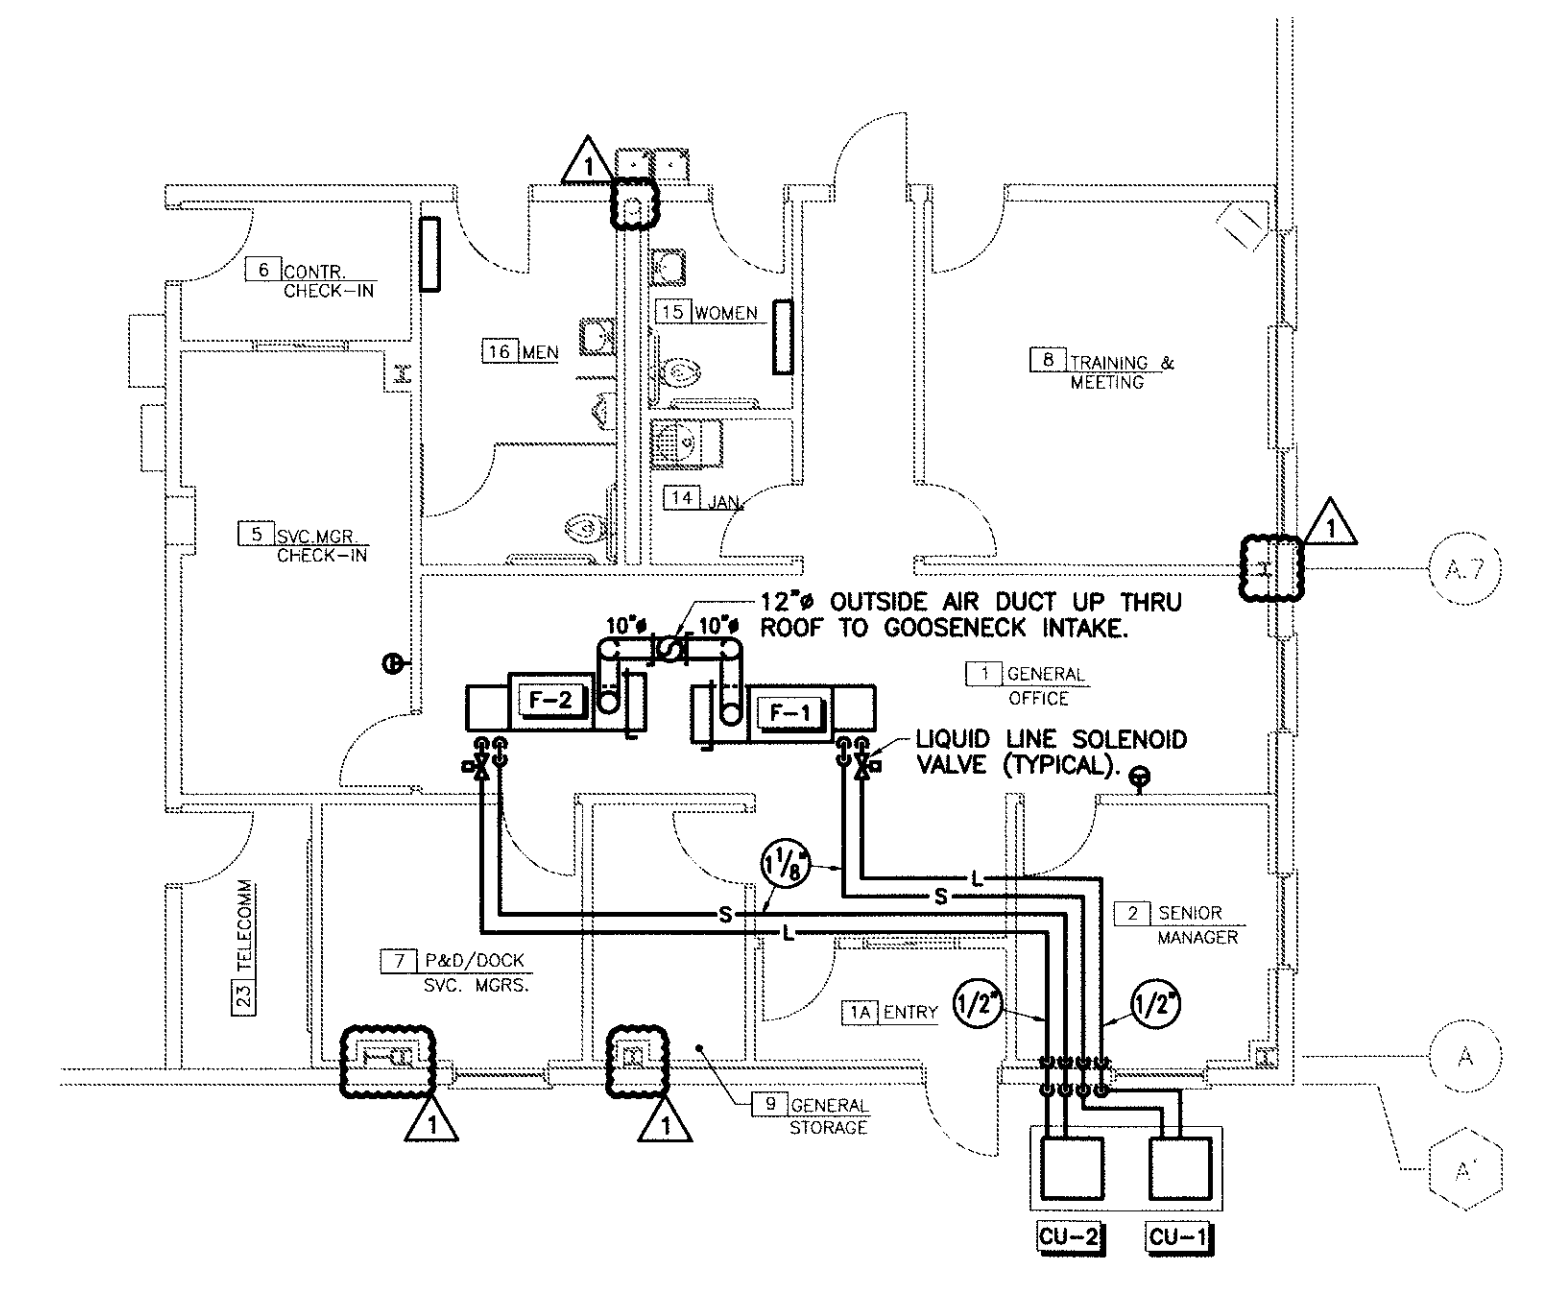