



FLOOR PLAN - PLUMBING
SCALE: 1/8"=1'-0"

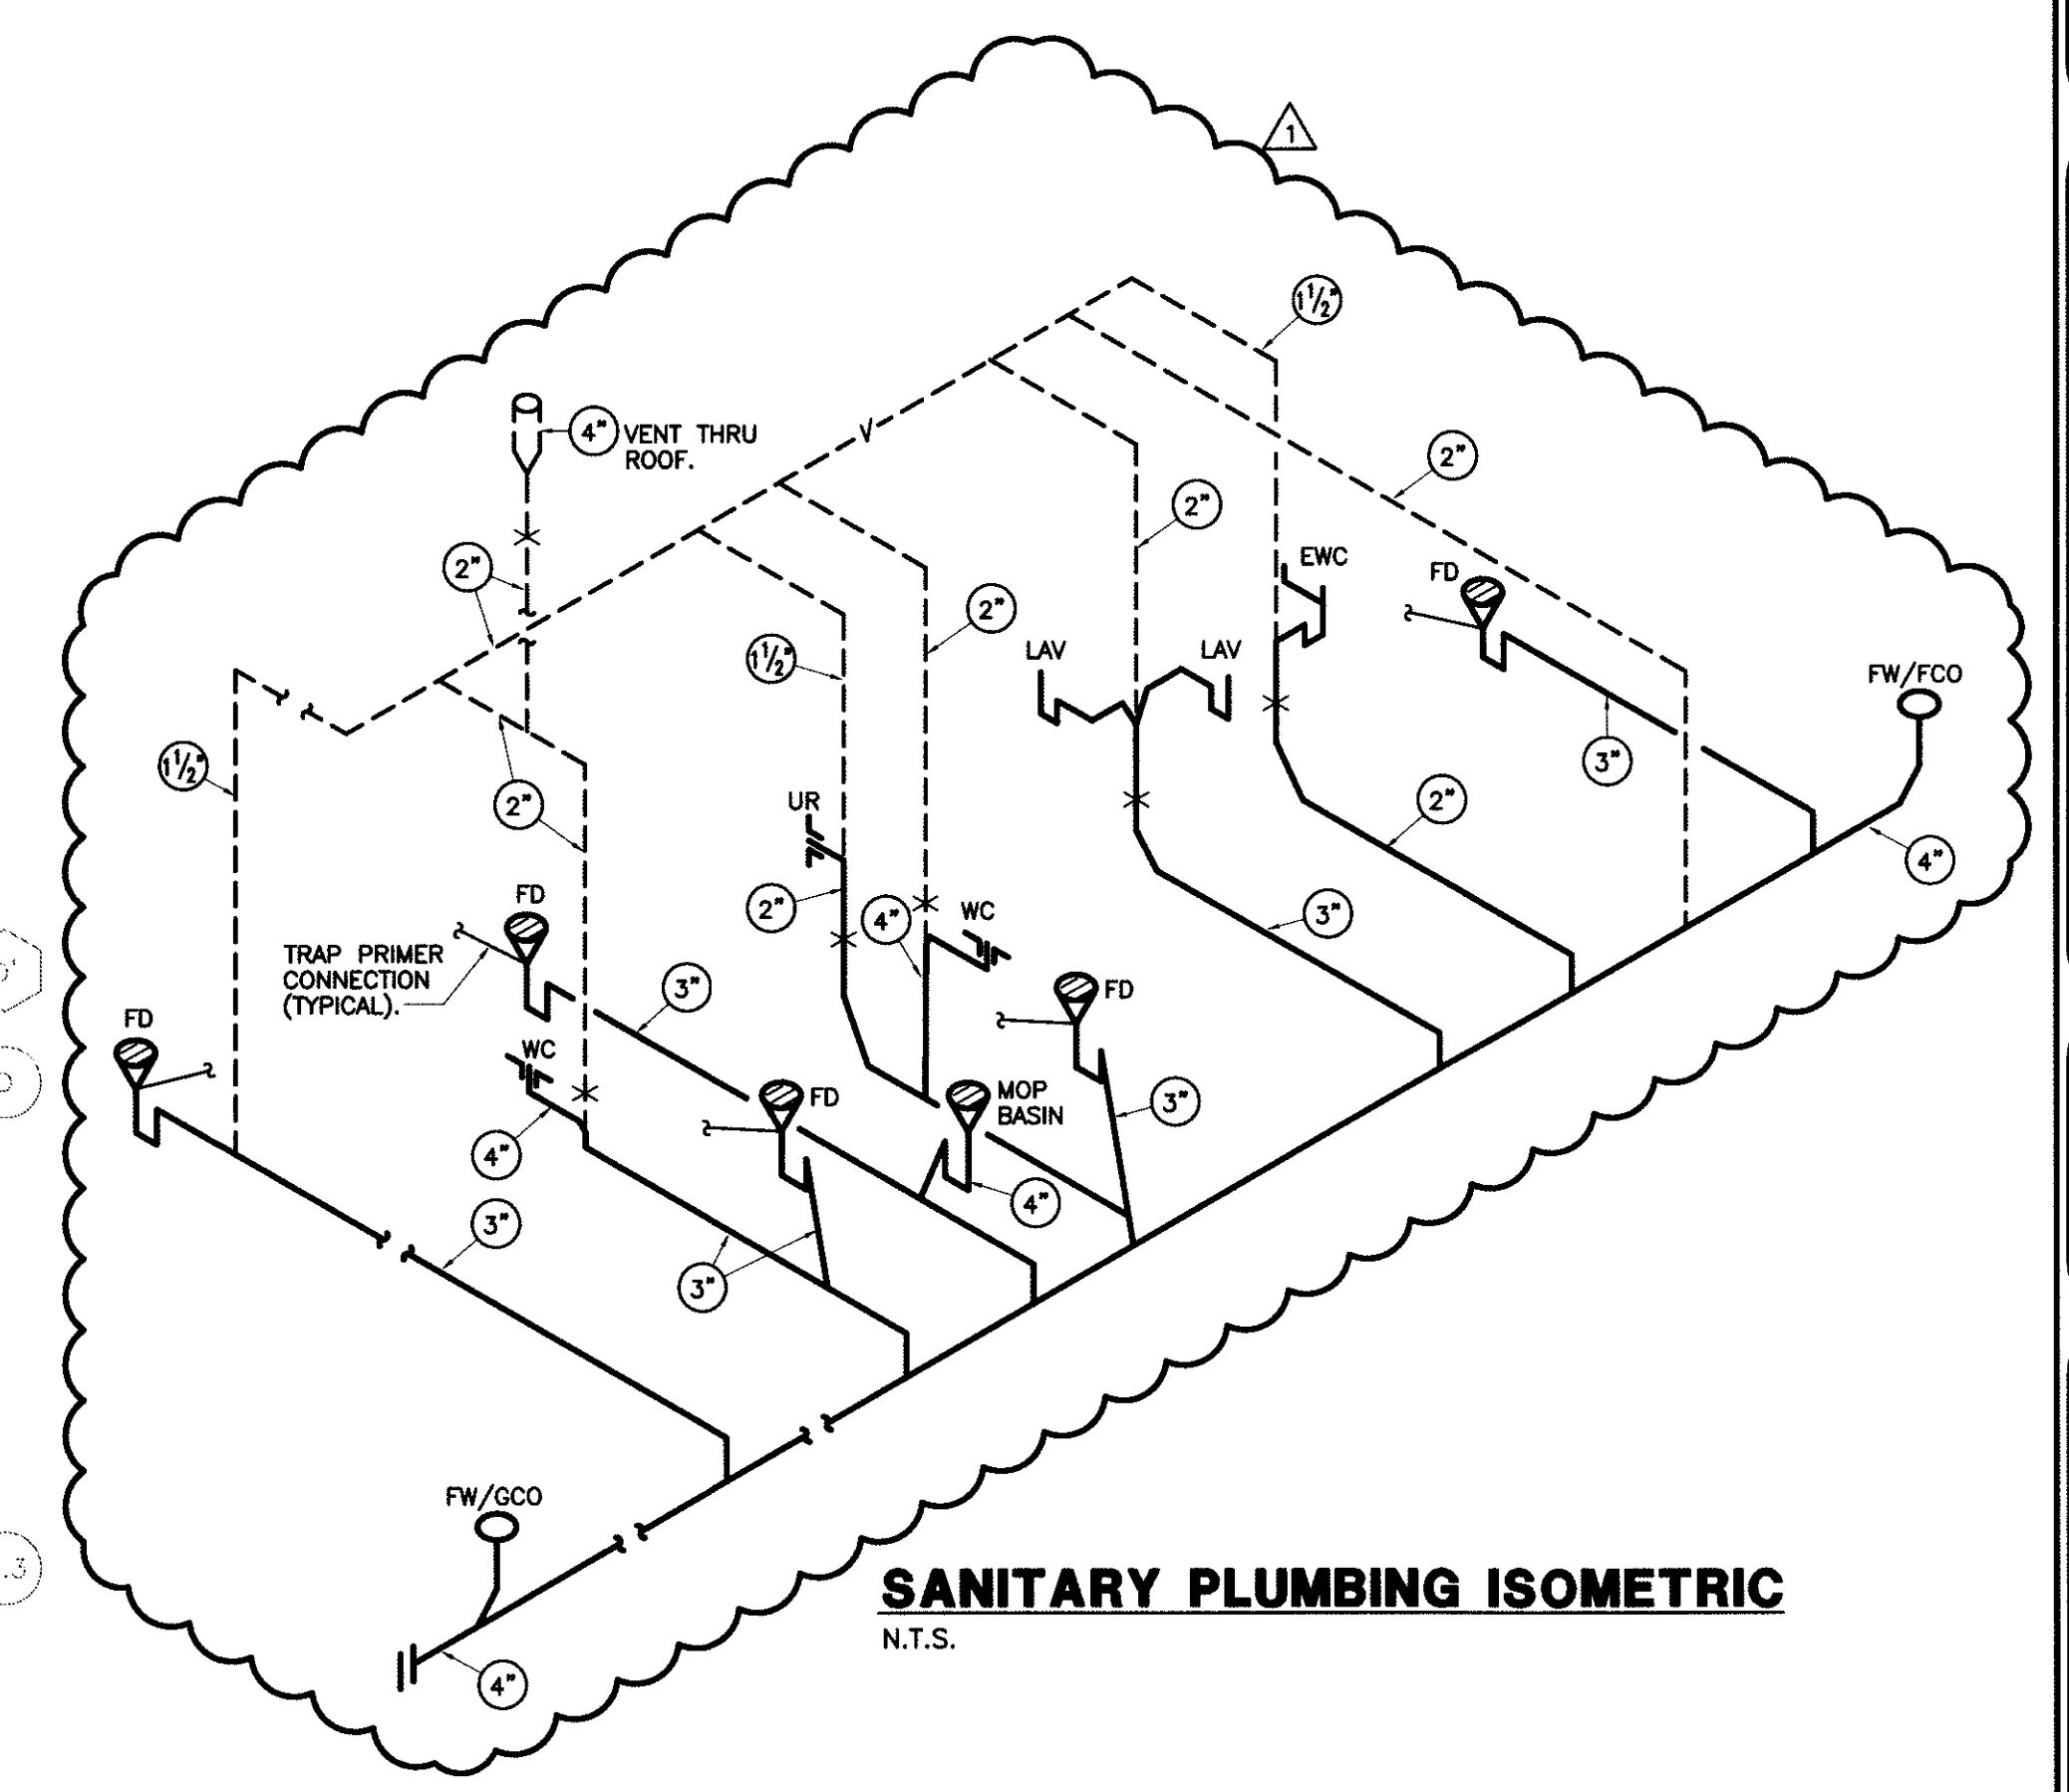

SANITARY PLUMBING ISOMETRIC
N.T.S.

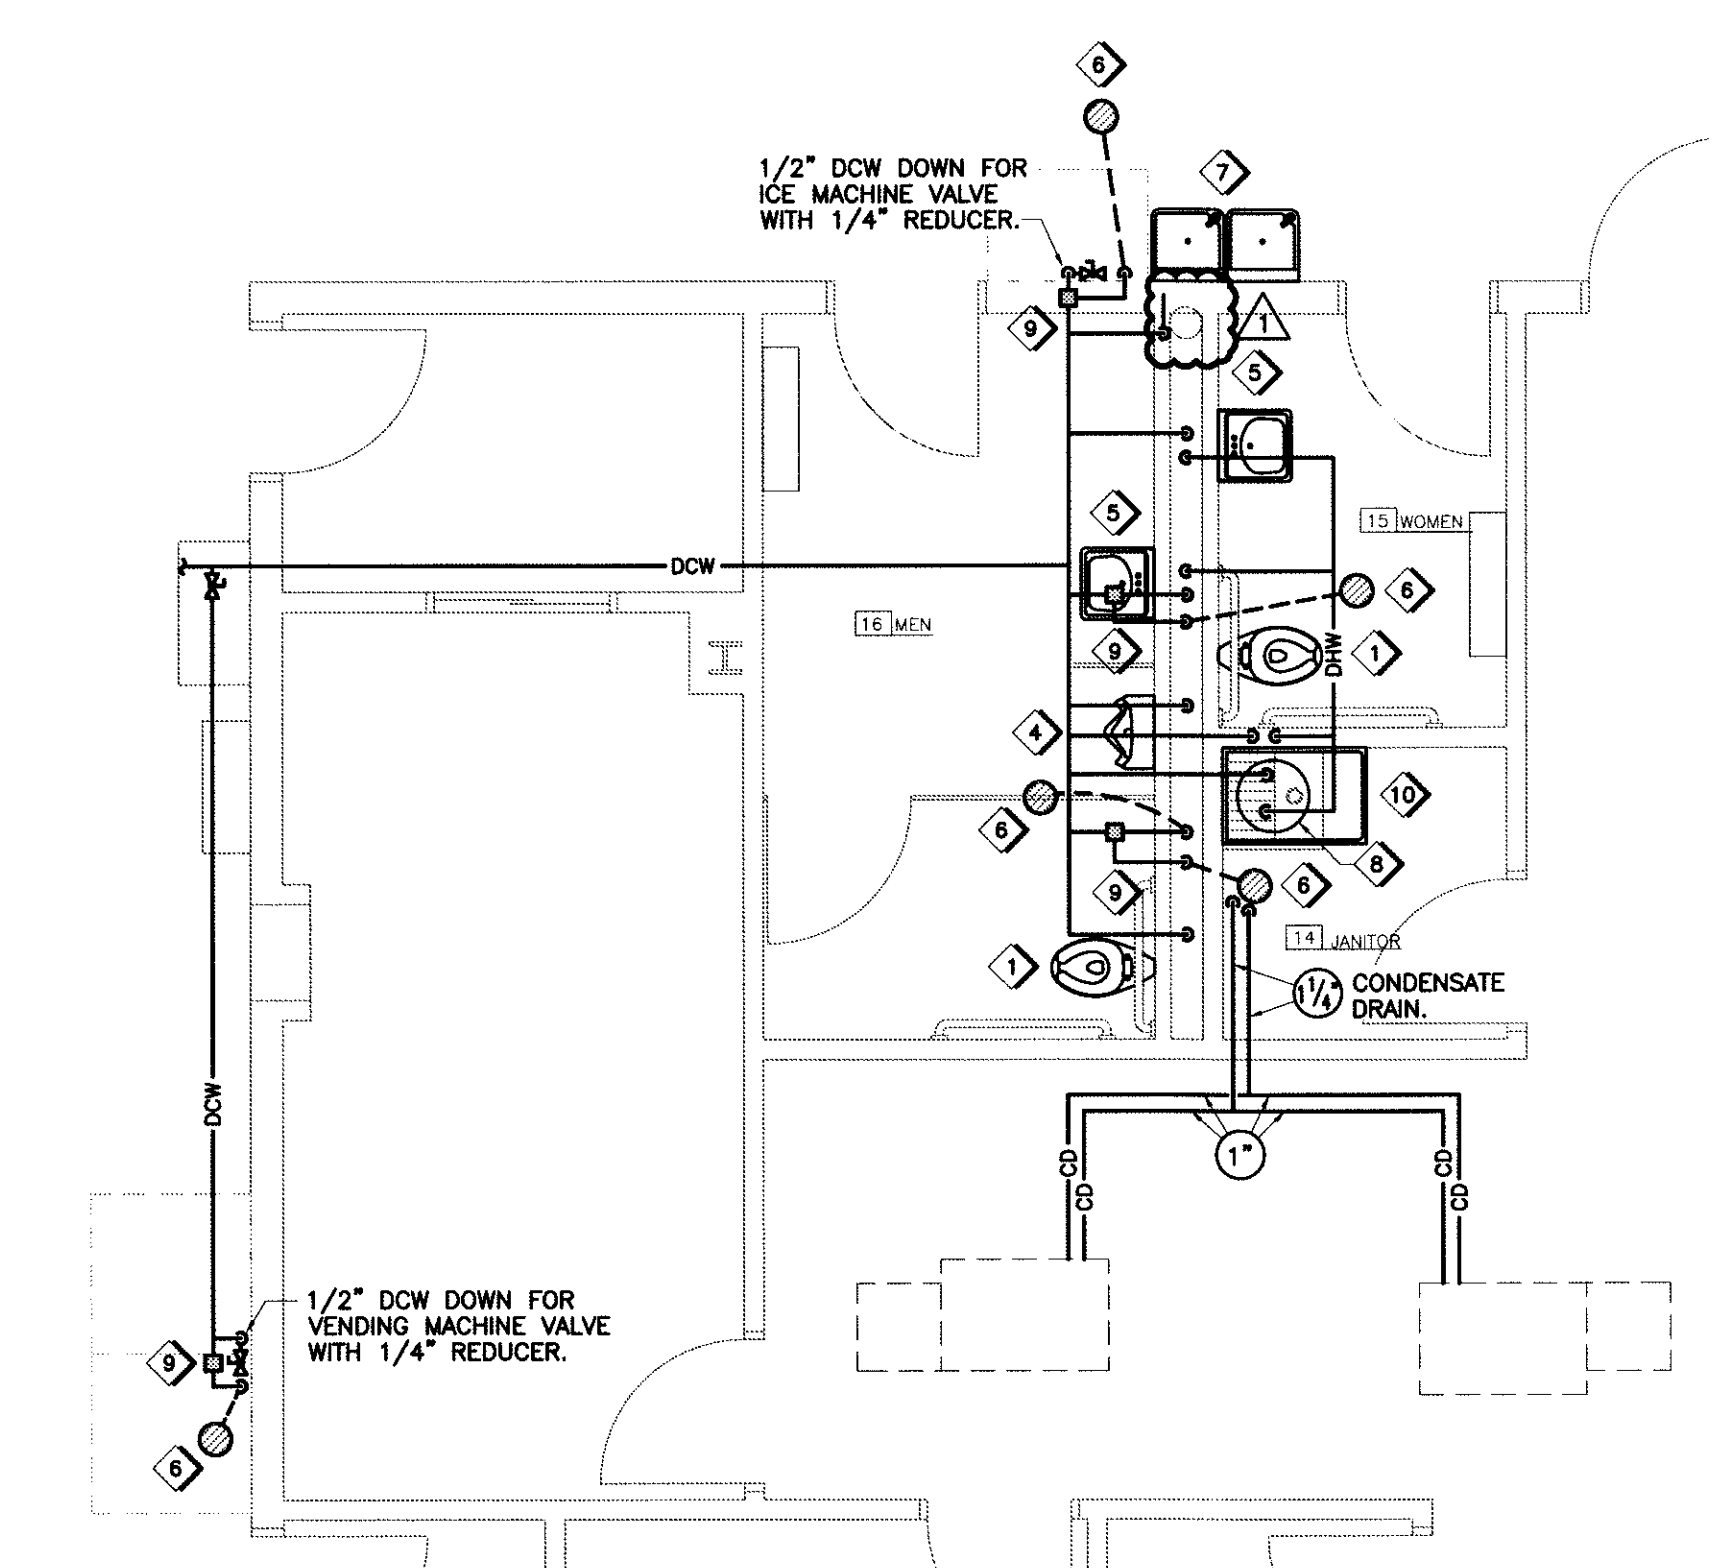

ENLARGED TOILET FLOOR PLAN - PLUMBING
SCALE: 1/4"=1'-0"

Cadfile: 40567 P200.dwg
PRJ: # C:\jobs\2007\57045\cod\ Date: 01/15/08



PROJECT NO. **P200**

REVISIONS
1/15/08

JOB NO. 40567
DATE 11/28/07
DRAWN BY K/H
CHECKED BY G.R.H.

GBC DESIGN, INC.
8978 W. Market St. Akron, OH 44398-8986
Phone 330-898-0228 Fax 330-898-8782

SAAD DEVELOPMENT CORPORATION
3601 SPRING HILL BUSINESS PARK, SUITE 200
MOBILE, AL 36608
PHONE: 251-478-7223
COPYRIGHT © 2007 SAAD DEVELOPMENT CORPORATION

FEDEX GROUND STATESBORO, GA.
PACKAGE DISTRIBUTION CENTER
3400 ZELL MILLER PARKWAY
STATESBORO, GA. 30458

FLOOR PLANS - PLUMBING & ISOMETRIC

SHEET NO. **P200**