



WESTGATE PARKWAY

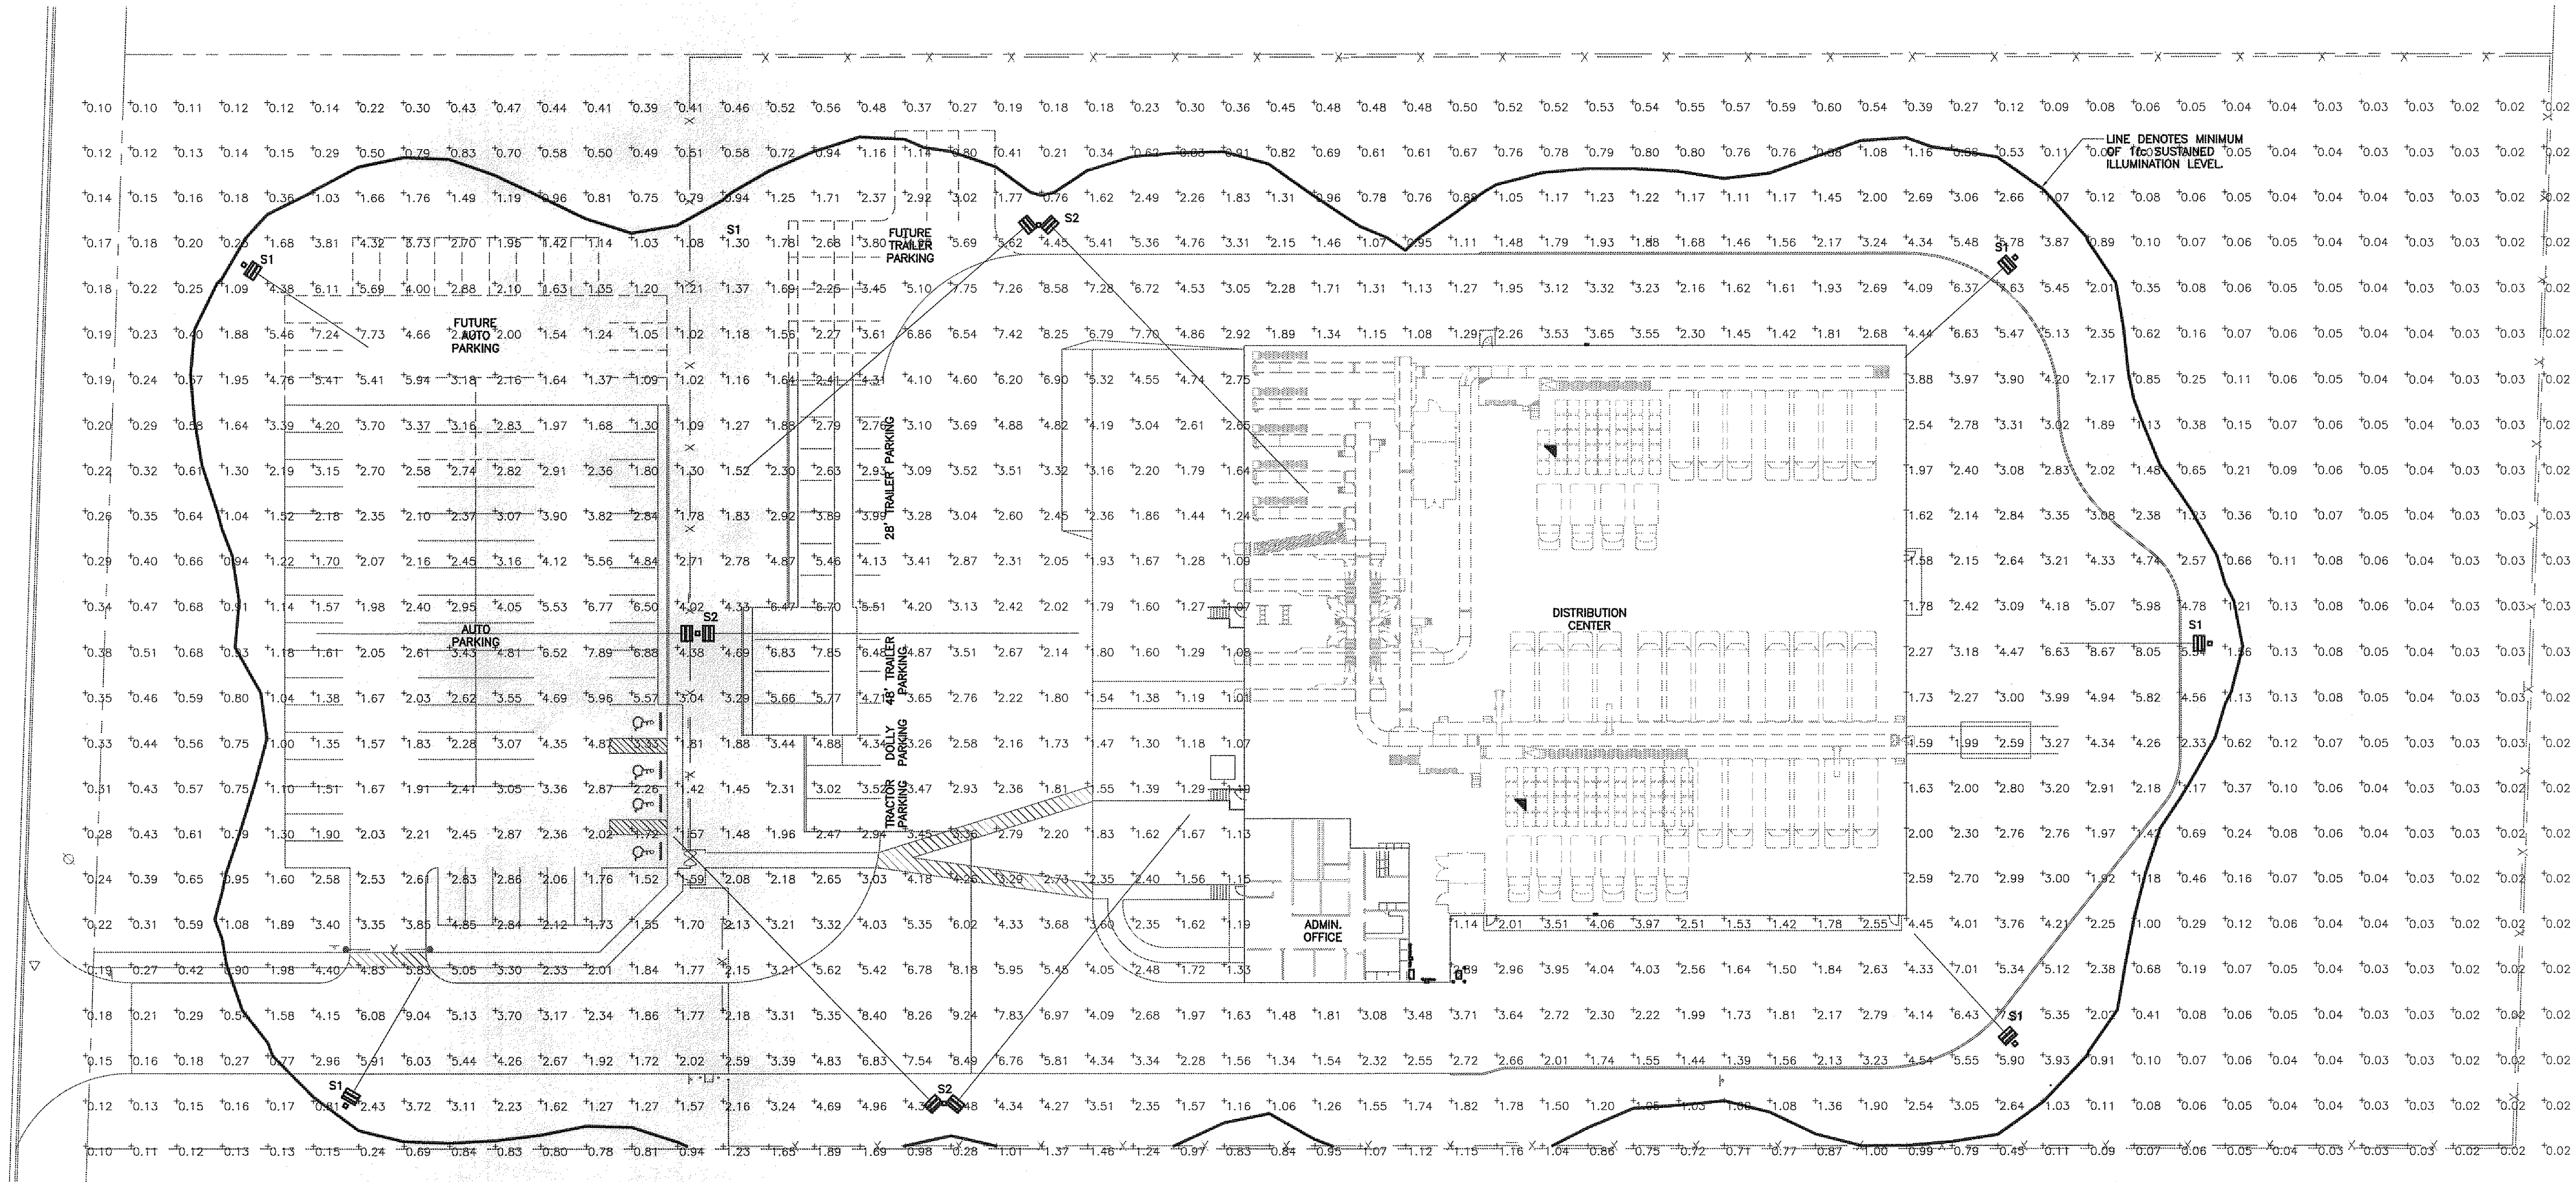

LIGHTING SCHEDULE								
TYPE	SYMBOL	LAMP	DESCRIPTION	BALLAST	MOUNTING	INPUT WATTS	MODEL	VOLTS
S1	☐→	(1) 1000W HPS	Single pole-mounted flood	AUTOTRANSFORMER	35' POLE	1100	DAYBRITE #FL10XS48-ISF-FBH2-2DB-RTS-1-35-G11-T24	480V 2P 2W
S2	☐→☐	(2) 1000W HPS	Double pole-mounted flood	AUTOTRANSFORMER	35' POLE	2200	DAYBRITE #FL10XS48-ISF-FBH2-2DB-RTS-1-35-G11-T24	480V 2P 2W

OVERALL PHOTOMETRIC SITE PLAN ←

SCALE: 1"=30'-0"

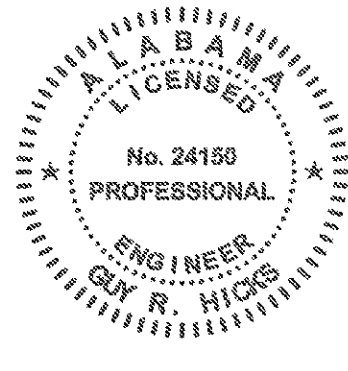

FEDEX GROUND DOTYAN PACKAGE DISTRIBUTION CENTER 4674 WESTGATE PARKWAY DOTYAN, AL 36303

OVERALL PHOTOMETRIC SITE PLAN
SHEET NO. **CE101**

SAAAD DEVELOPMENT CORPORATION
3601 SPRING HILL BUSINESS PARK, SUITE 200
MOBILE, AL 36608
PHONE: 251-478-7223
COPYRIGHT © 2007 SAAAD DEVELOPMENT CORPORATION
All rights reserved. No part of this document may be reproduced or transmitted in any form or by any means, electronic or mechanical, including photocopying, recording, or by any information storage and retrieval system, without the prior written permission of SAAAD DEVELOPMENT CORPORATION.

GBC DESIGN, INC.
8878 W. Market St.
Akron, OH 44388-8906
Phone: 888-888-8782
Fax: 888-888-0228

FedEx GROUND
FedEx Home Delivery
Co-Location

JOB NO. 40539
DATE 11/19/07
DRAWN BY K/H
CHECKED BY G.R.H.

REVISIONS