





ENLARGED FLOOR PLAN - LIGHTING
 SCALE: 1/8"=1'-0"

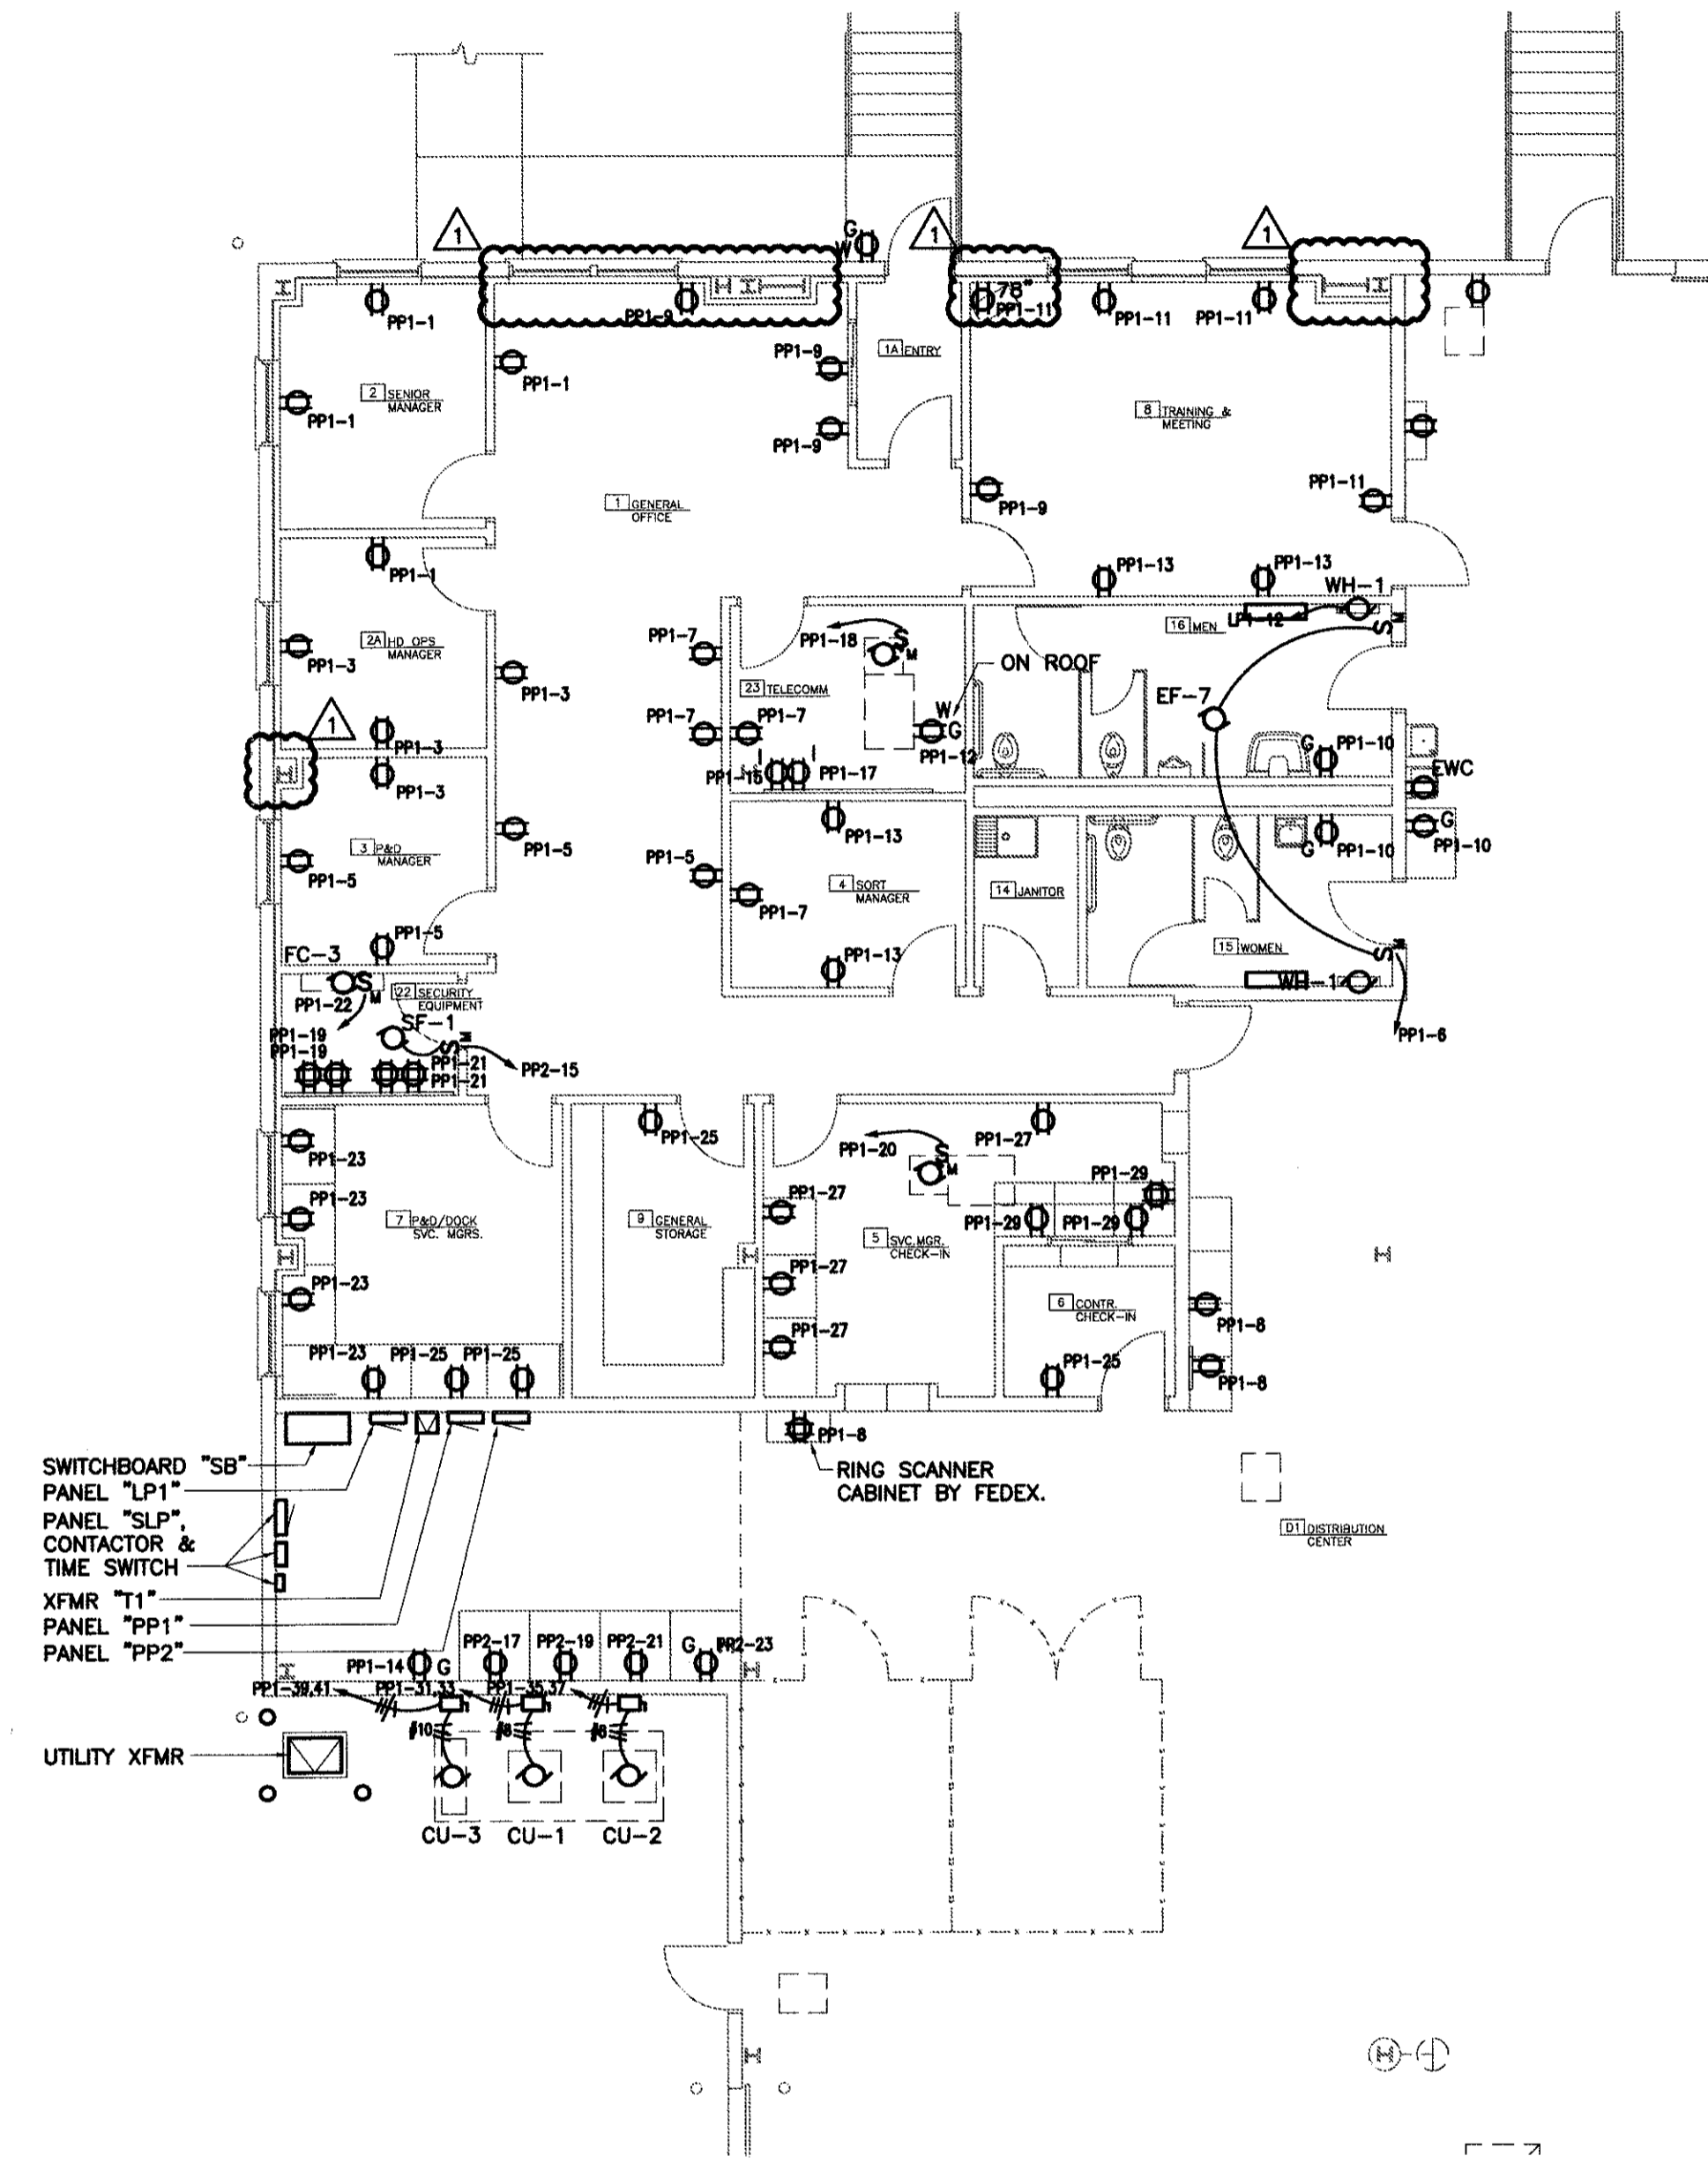

ENLARGED FLOOR PLAN - POWER
 SCALE: 1/8"=1'-0"

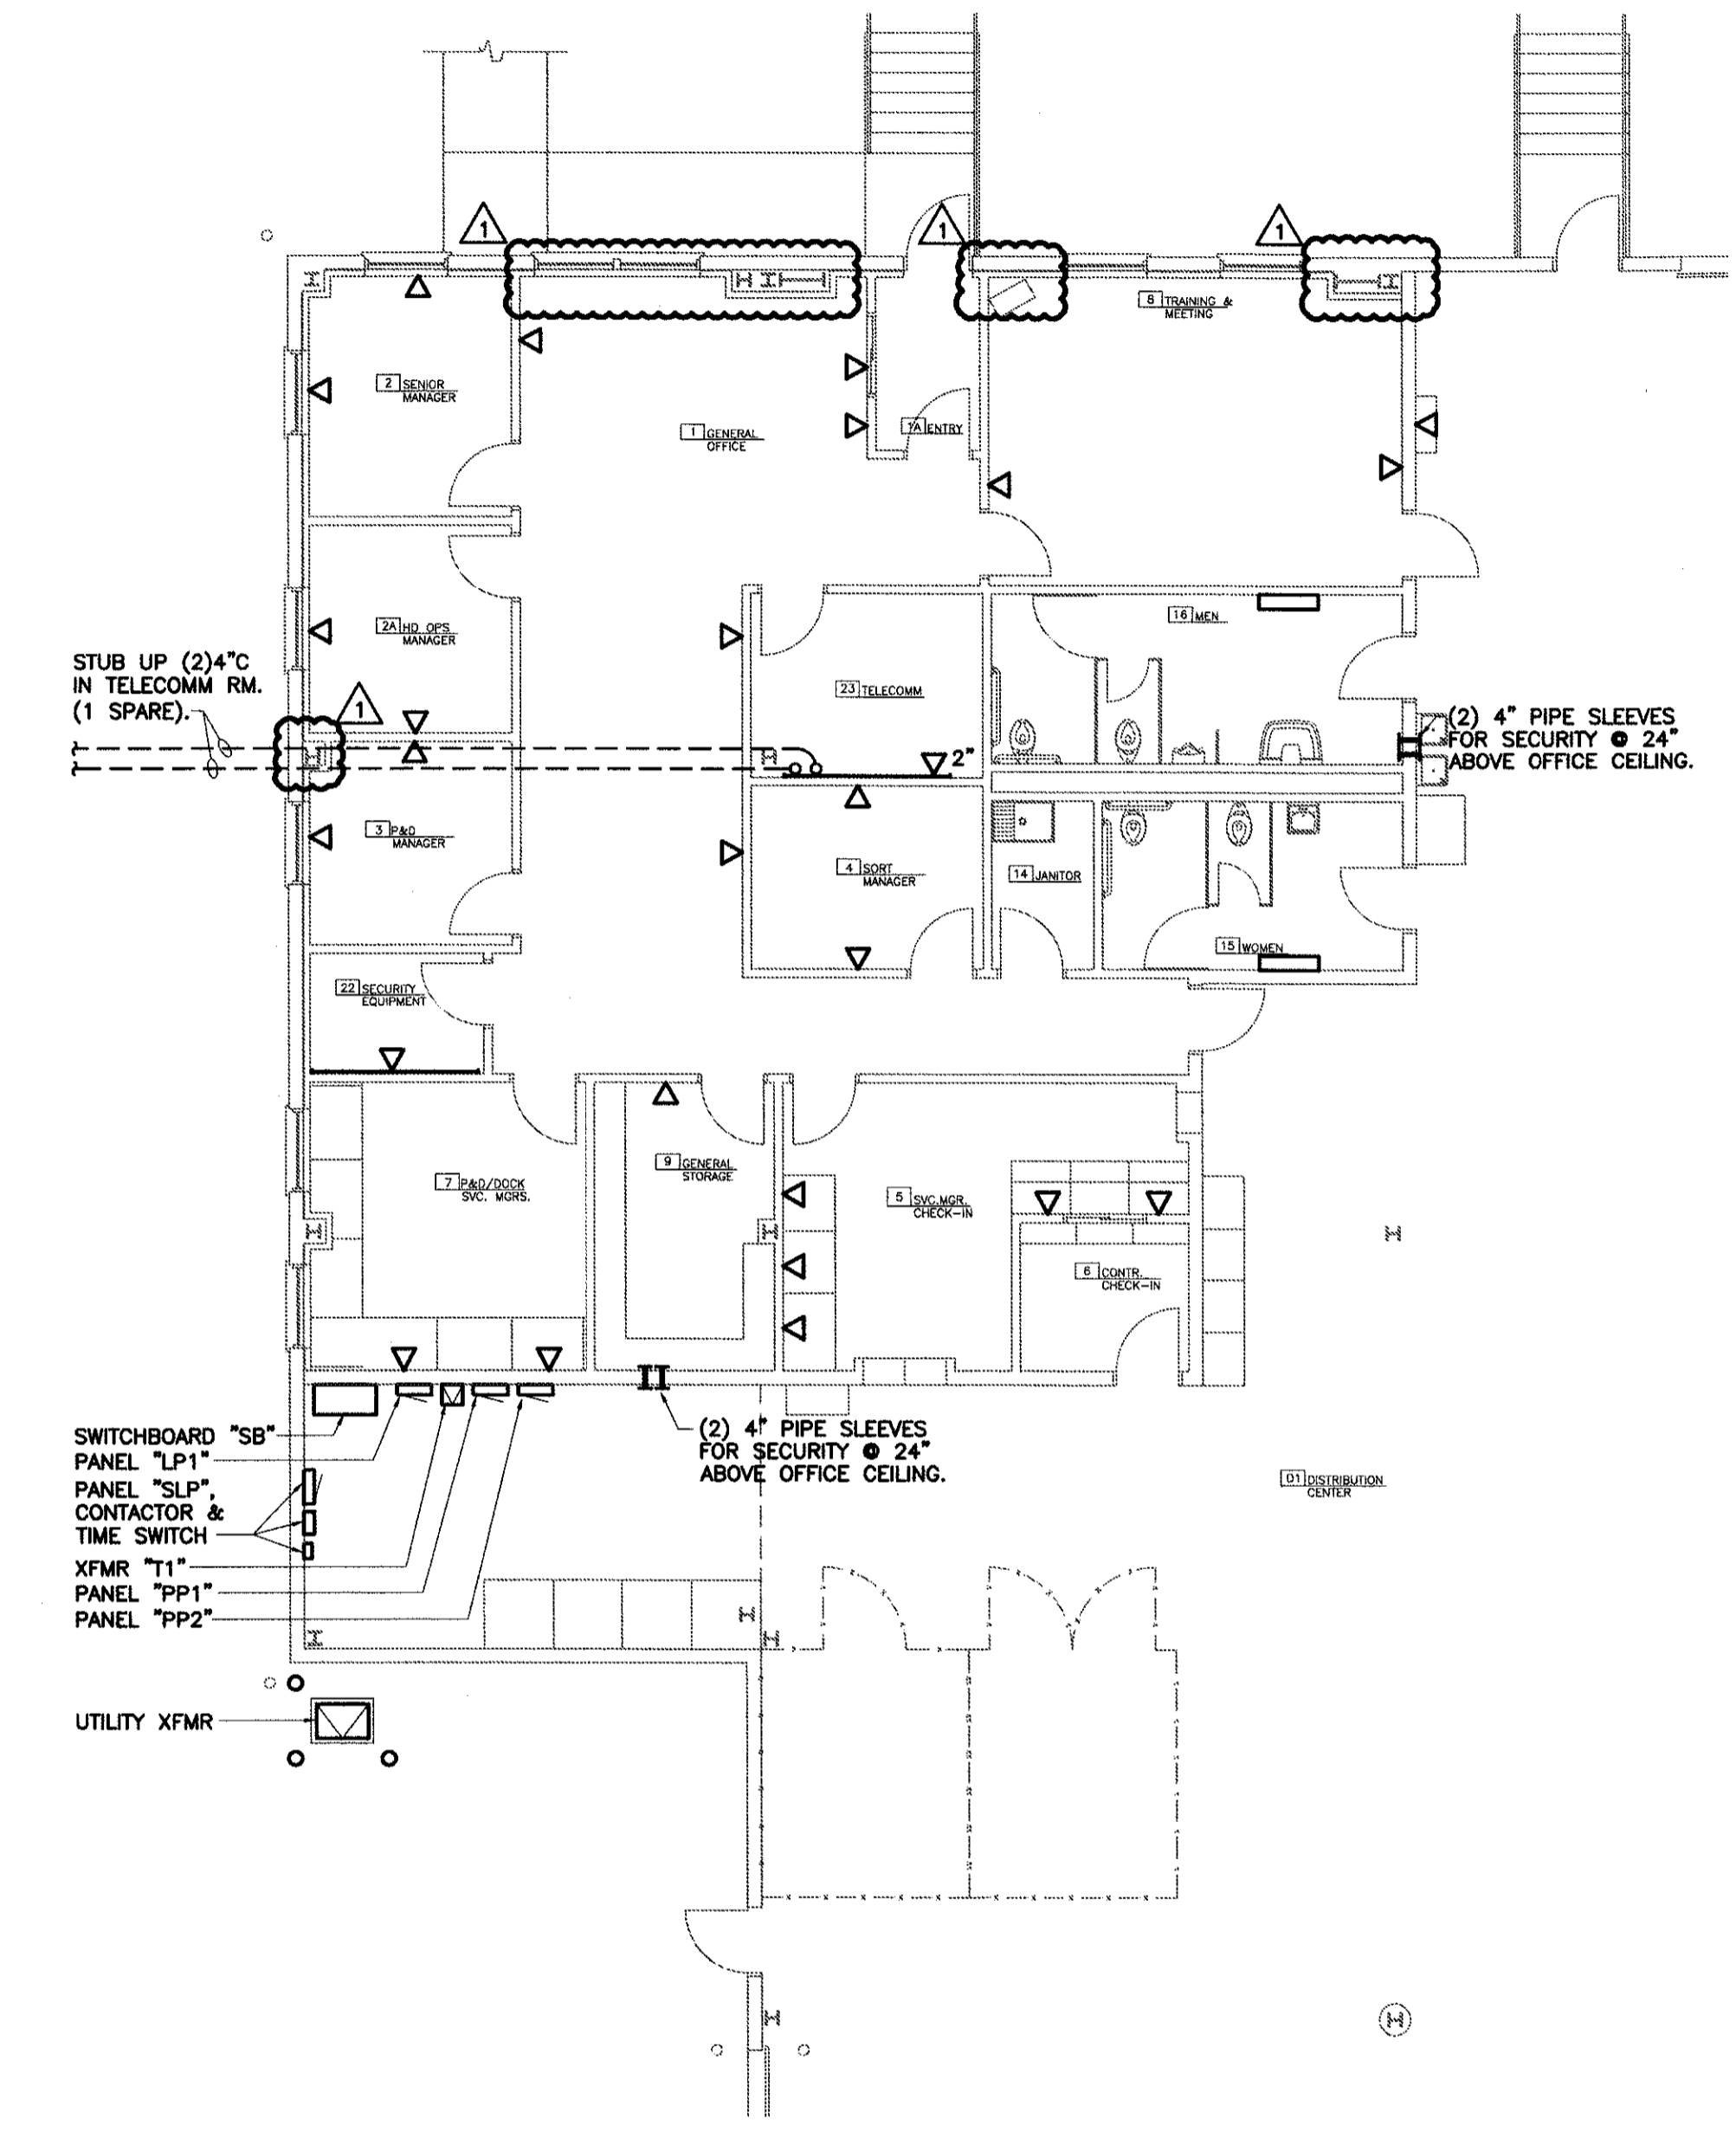

ENLARGED FLOOR PLAN - SYSTEMS
 SCALE: 1/8"=1'-0"

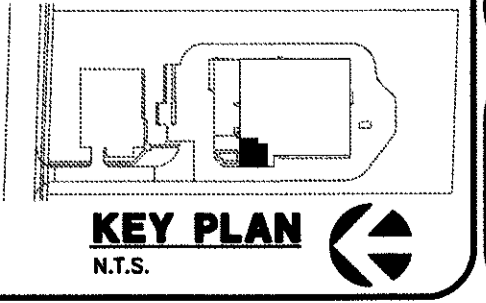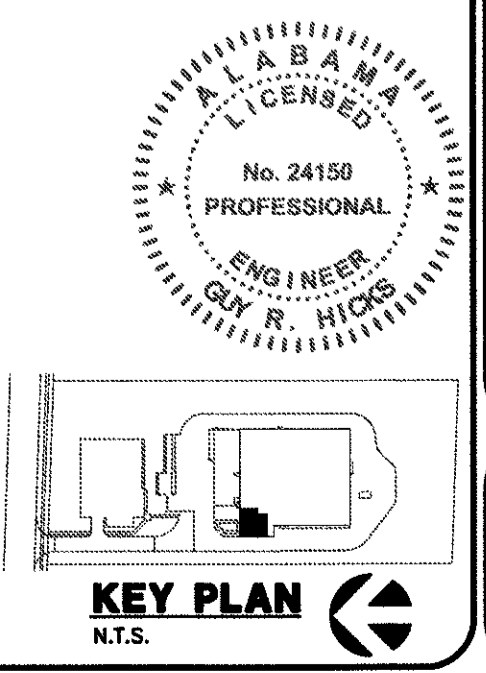

Cadfile: 40539 E400.dwg
 PROJ: G:\Jobs\2007\07041\cod\
 Date: 01/10/08